


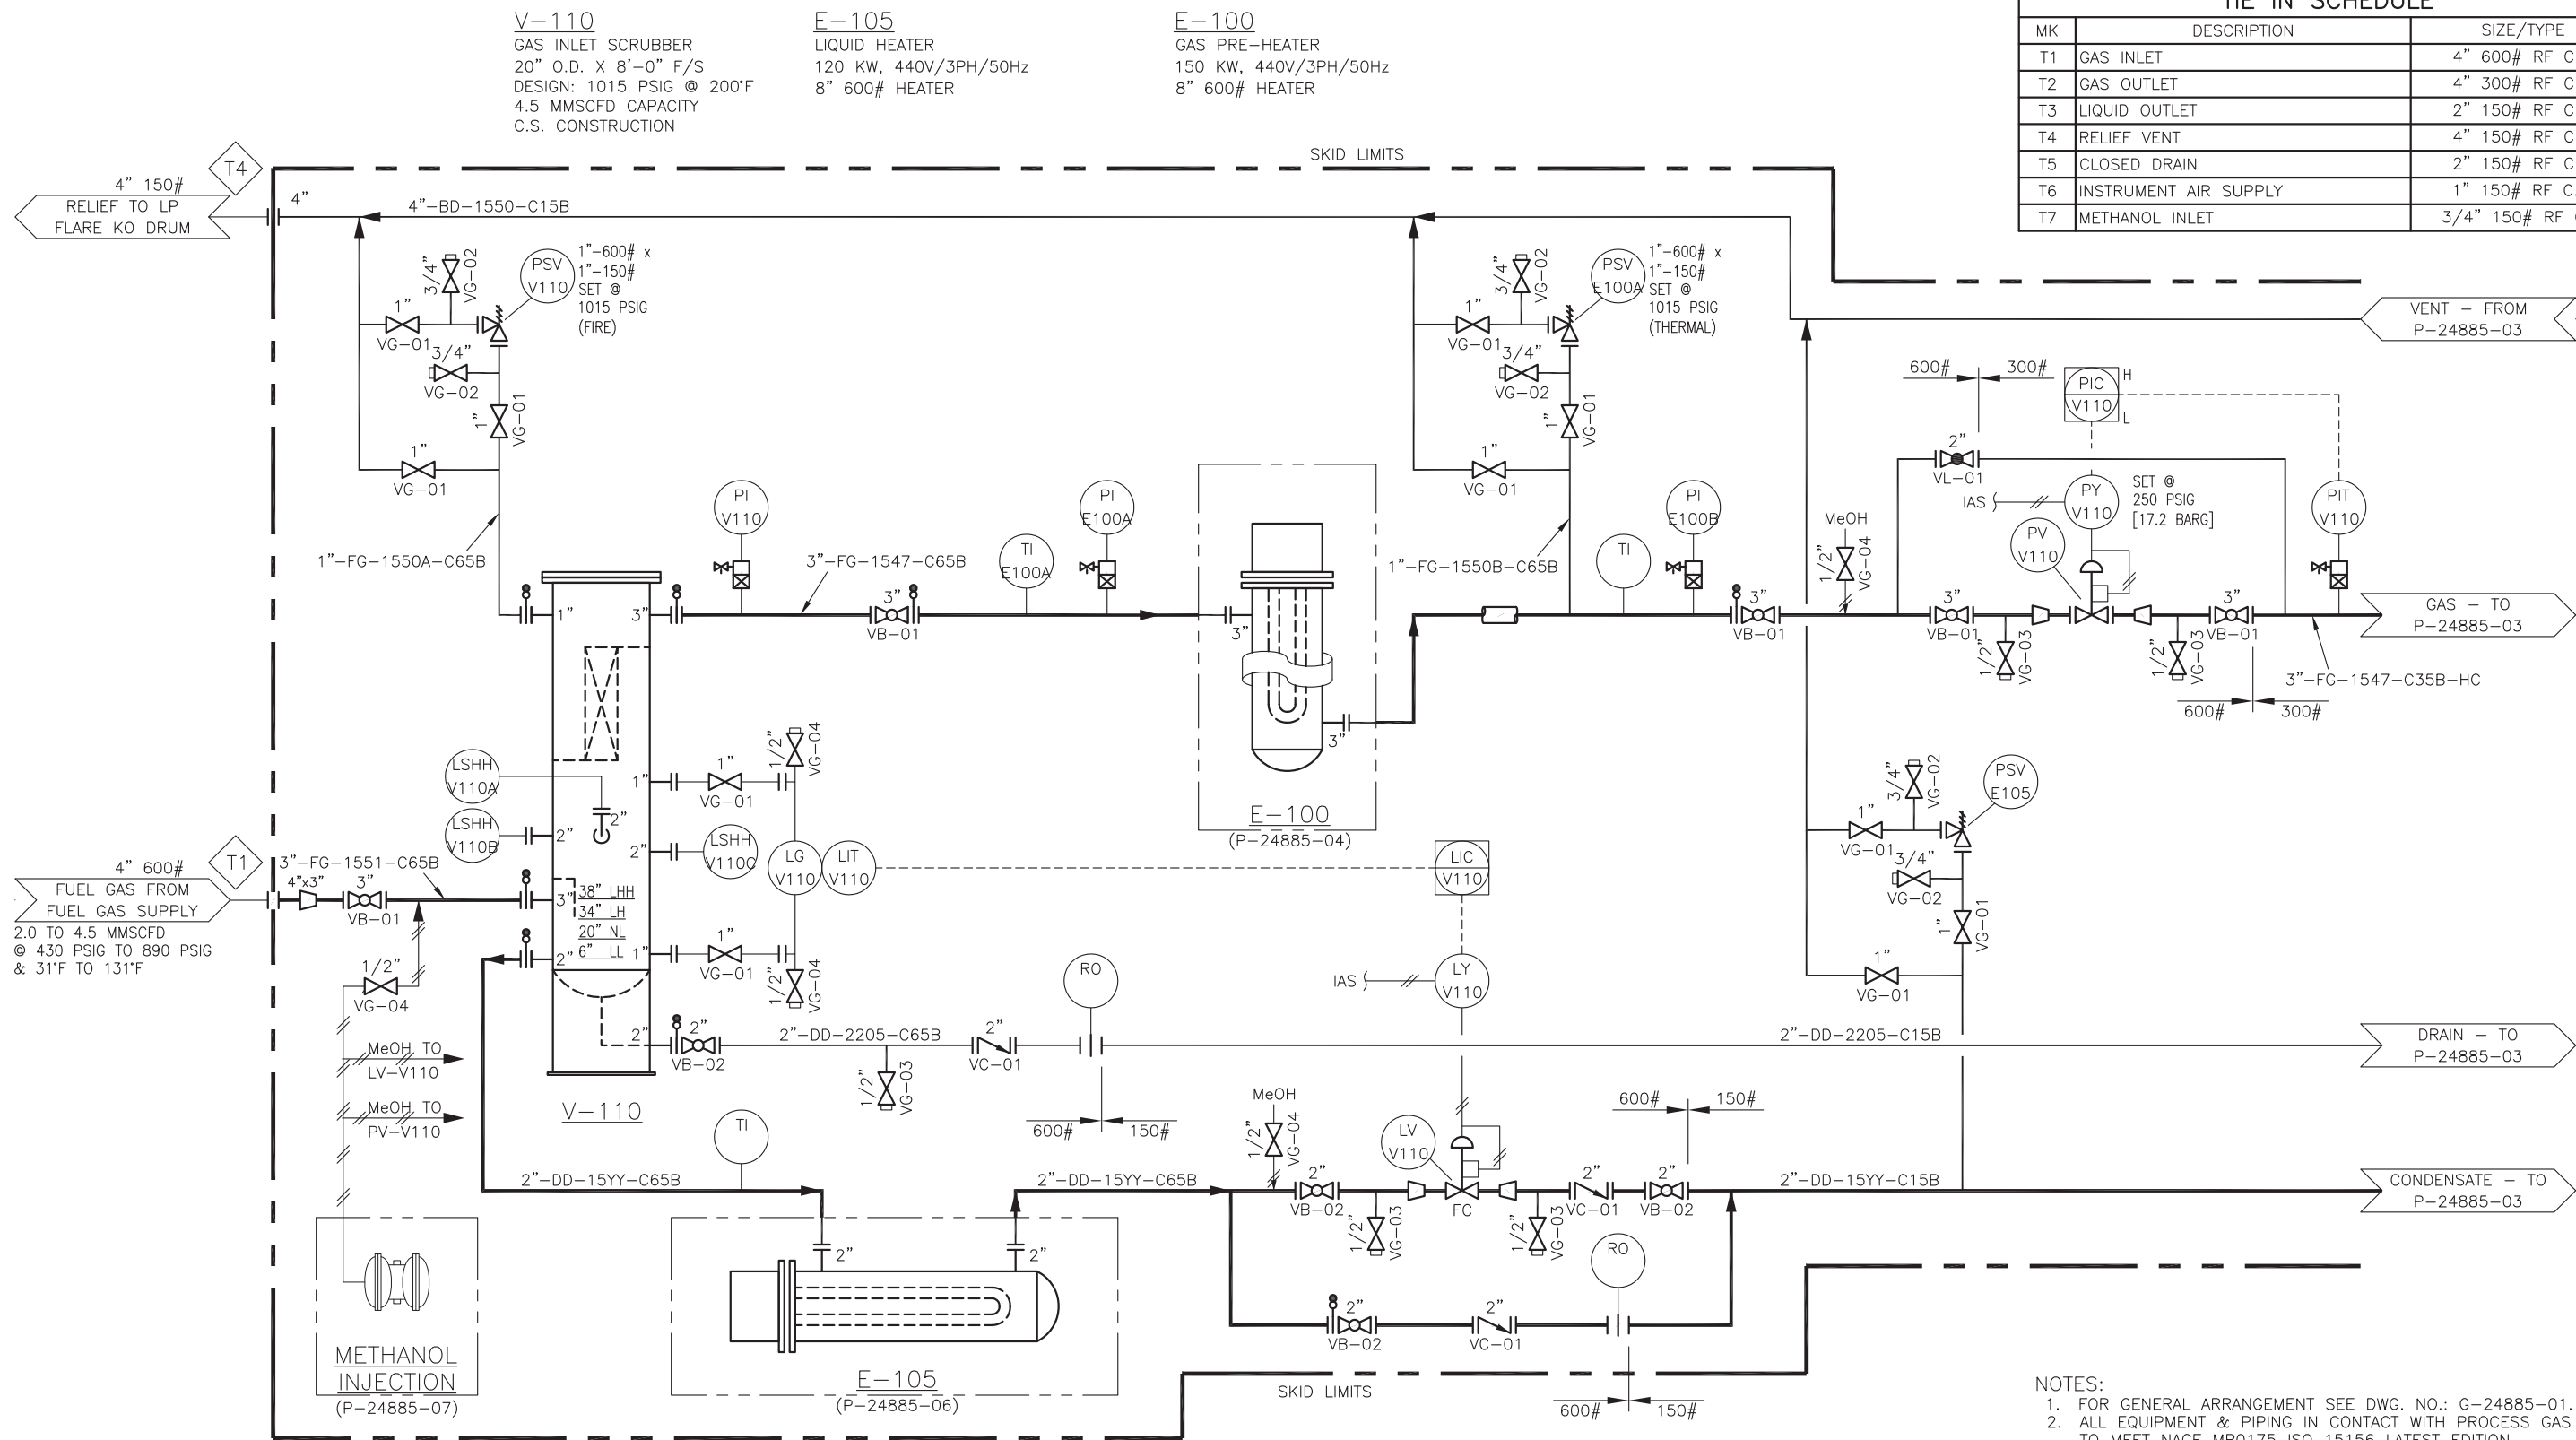

TIE IN SCHEDULE		
MK	DESCRIPTION	SIZE/TYPE
T1	GAS INLET	4" 600# RF C.S.
T2	GAS OUTLET	4" 300# RF C.S.
T3	LIQUID OUTLET	2" 150# RF C.S.
T4	RELIEF VENT	4" 150# RF C.S.
T5	CLOSED DRAIN	2" 150# RF C.S.
T6	INSTRUMENT AIR SUPPLY	1" 150# RF C.S.
T7	METHANOL INLET	3/4" 150# RF C.S.

- NOTES:
- FOR GENERAL ARRANGEMENT SEE DWG. NO.: G-24885-01.
 - ALL EQUIPMENT & PIPING IN CONTACT WITH PROCESS GAS TO MEET NACE MR0175 ISO 15156 LATEST EDITION.



**INTEGRATED
FLOW SOLUTIONS**
6461 REYNOLDS RD, TYLER, TEXAS, USA 75708
PHONE NUMBER: +1 (903) 595-6511
FAX NUMBER: +1 (903) 595-4861

THIS DRAWING IS THE PROPERTY OF INTEGRATED FLOW SOLUTIONS AND SHALL NOT BE REPRODUCED, COPIED, LENT, NOR USED FOR ANY PURPOSE OTHER THAN THAT WHICH IT IS FURNISHED EXCEPT BY WRITTEN PERMISSION.

B	###	ISSUED FOR CUSTOMER APPROVAL	RM
A	16SEP09	ISSUED FOR CUSTOMER APPROVAL	RM
REV.	DATE	DESCRIPTION	BY

ENGINEERED BY:
J. BERMUDEZ
APPROVED/DATE:

DESIGNED BY:
R. MILEY
CHECKED/DATE:

PROJECT MANAGER:
D. POLLAN

PROCESS UNLIMITED/KOC
KUWAIT OIL COMPANY
FUEL GAS CONDITIONING
TAG NUMBER: TBD
PURCHASE ORDER NUMBER: MOPD-001/P.O.0068
IFS JOB NUMBER: 24885
INTEGRATED FLOW SOLUTIONS, TYLER, TEXAS

**PIPING & INSTRUMENTATION
DIAGRAM**
HP FUEL GAS CONDITIONING

www.IFSolutions.com